


ALL TRENCHES IN EXPOSED ROCK TO BE LINED WITH LIQUID BITUMEN SPRAY IMMEDIATELY AFTER EXPOSURE.


- NOTES:
- DO NOT SCALE. USE FIGURED DIMENSIONS ONLY.
 - THIS DRAWING IS TO BE READ IN CONJUNCTION WITH ALL OTHER RELEVANT ARCHITECTURAL AND ENGINEERING DRAWINGS.

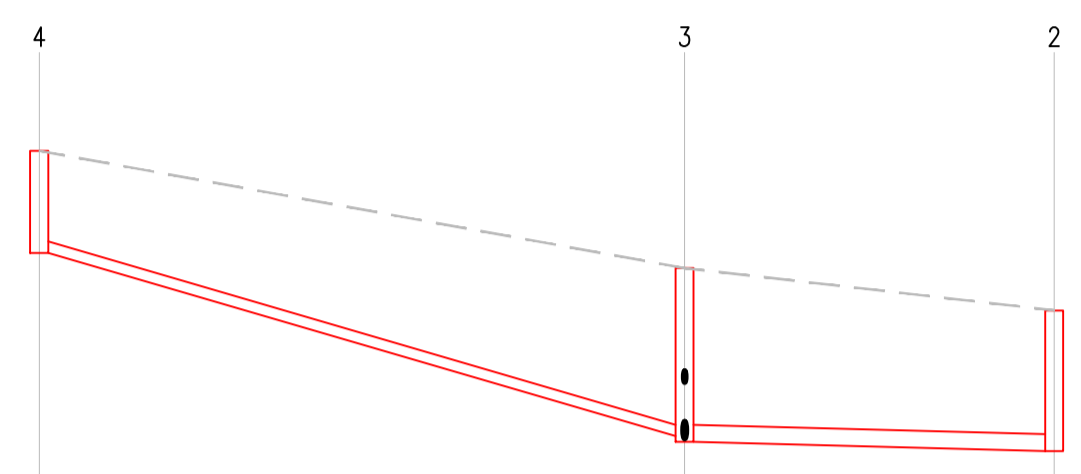

Datum = 89.0

Link Name	4	3	2
Section Type	150mm	225mm	225mm
Slope	1:17.6	1:200.4	1:200.4
Cover Level	94.700	93.150	92.590
Invert Level	93.350	90.927 90.852	90.730
Length	42.675	24.450	


Horizontal Scale 1:500
Vertical Scale 1:100

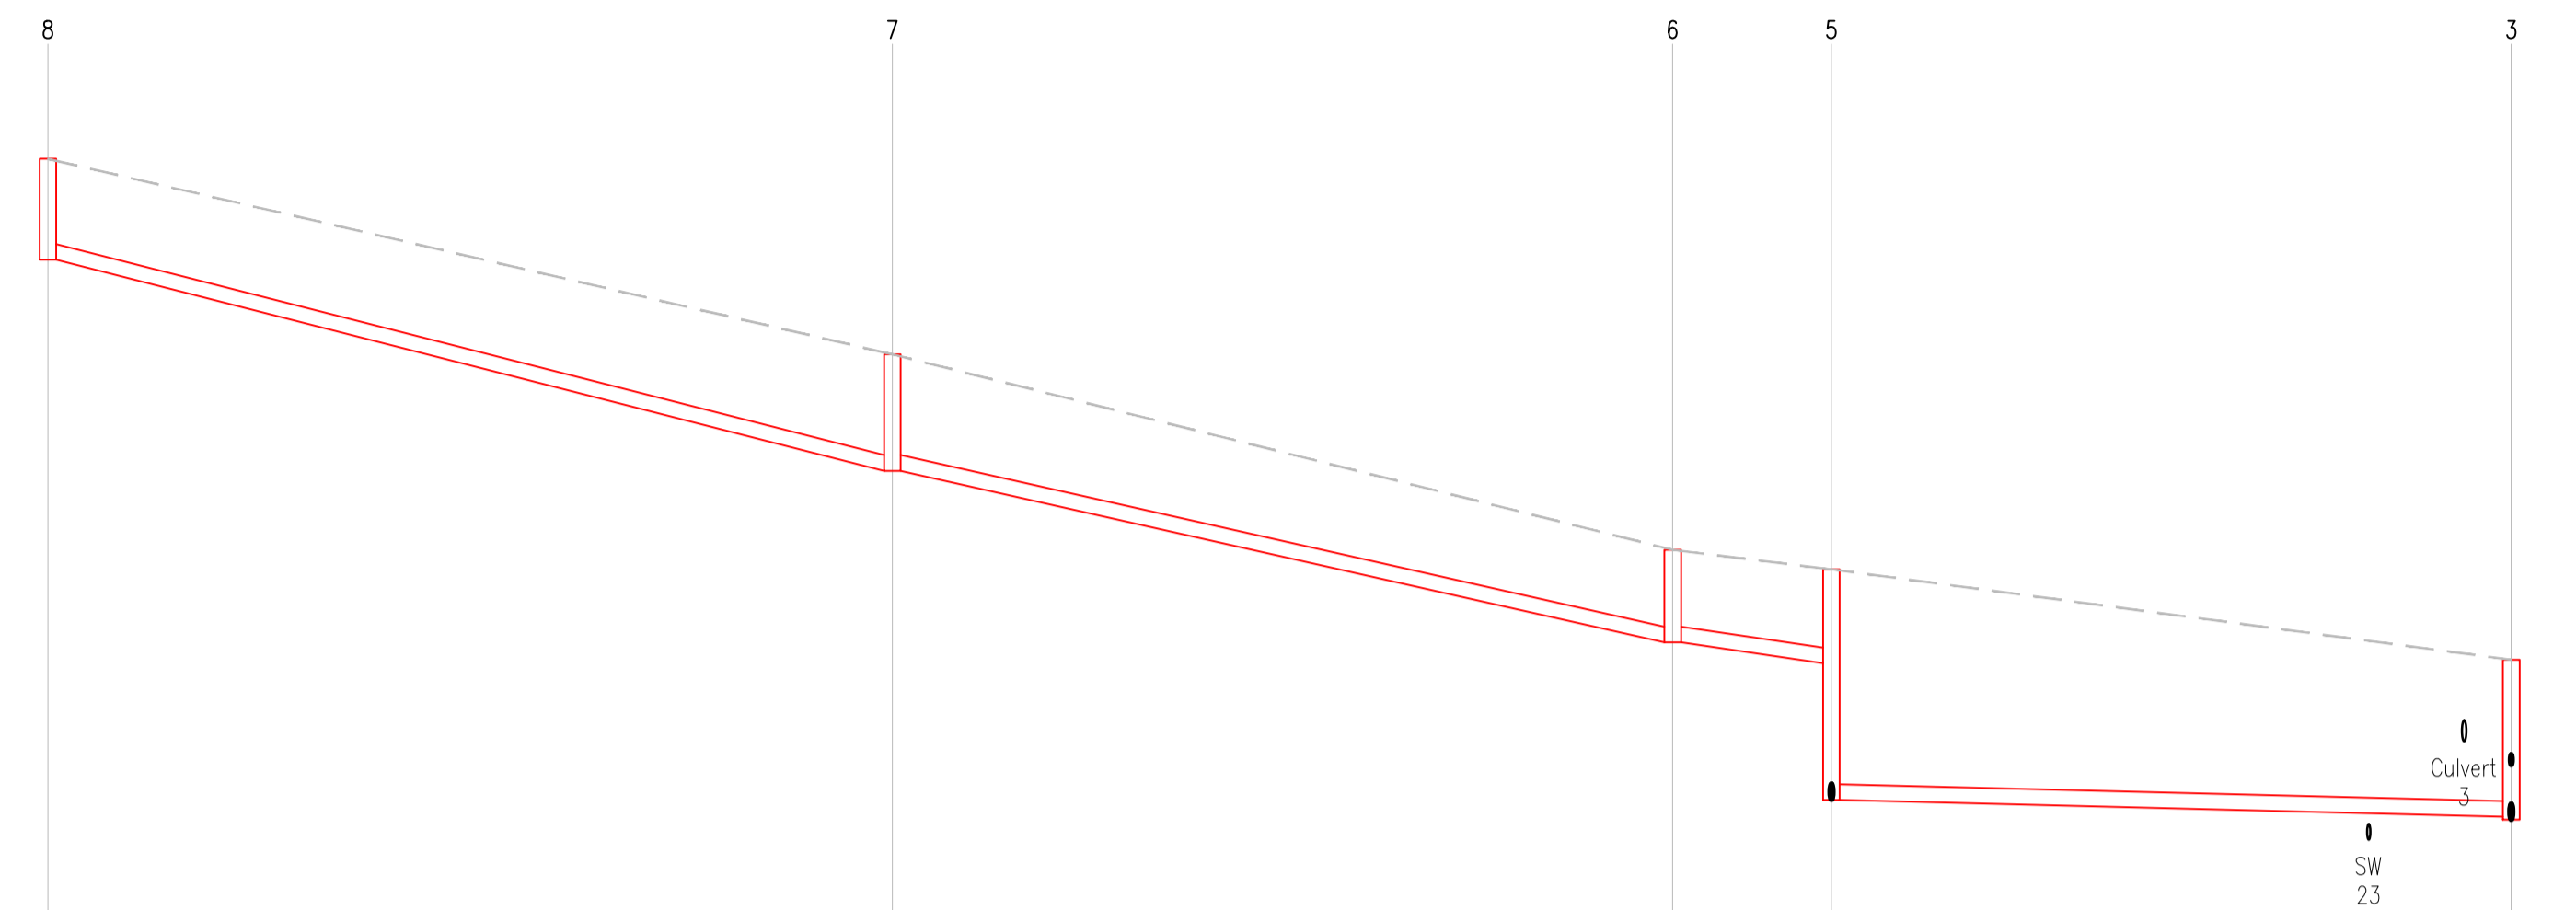

Datum = 89.0

Link Name	8	7	6	5	3
Section Type	225mm	225mm	225mm	225mm	225mm
Slope	1:20.0	1:22.7	1:38.0	1:200.2	1:200.2
Cover Level	100.350	97.540	94.730	94.450	93.150
Invert Level	98.900	95.868 95.866	93.400 93.400	93.100 91.137	90.893
Length	60.687	56.072	11.404	48.857	


Horizontal Scale 1:500
Vertical Scale 1:100

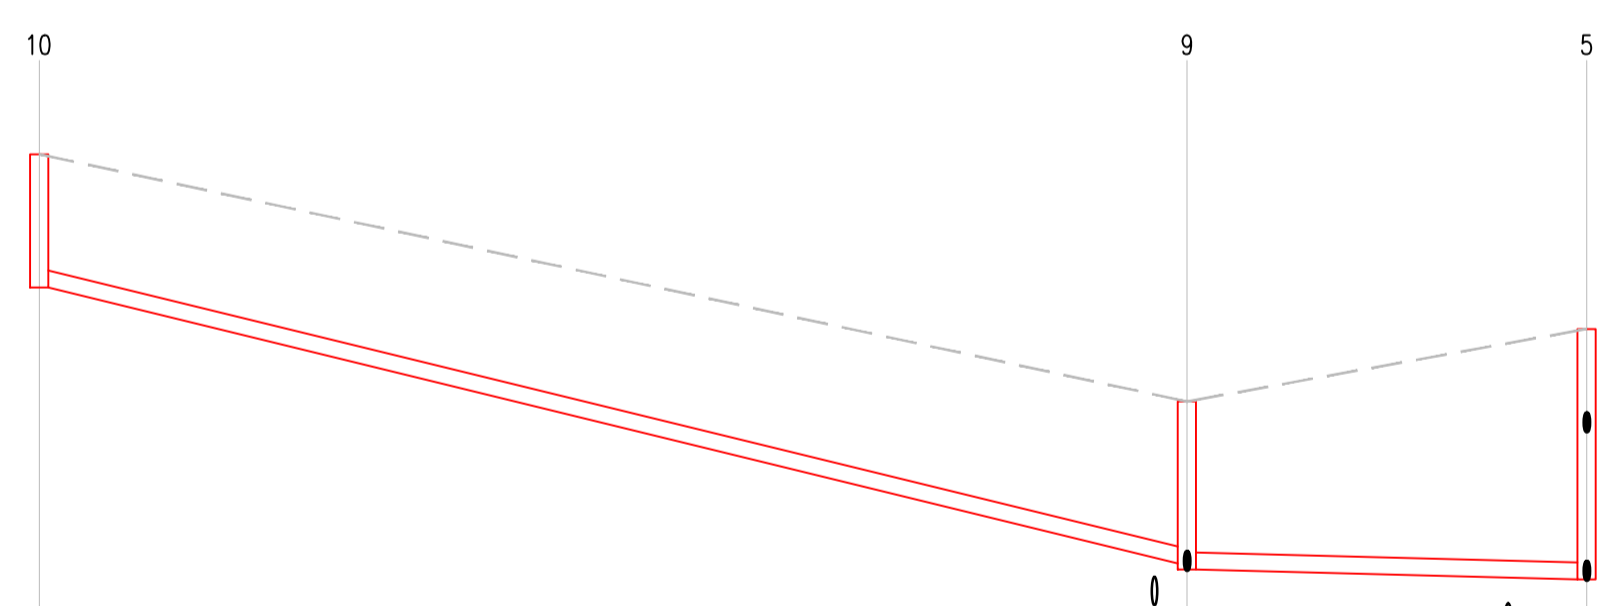

Datum = 90.0

Link Name	10	9	5
Section Type	225mm	225mm	225mm
Slope	1:20.8	1:200.3	1:199.9
Cover Level	96.761	93.491	94.450
Invert Level	95.000	91.351 91.269	91.137
Length	75.898	26.440	

Horizontal Scale 1:500
Vertical Scale 1:100

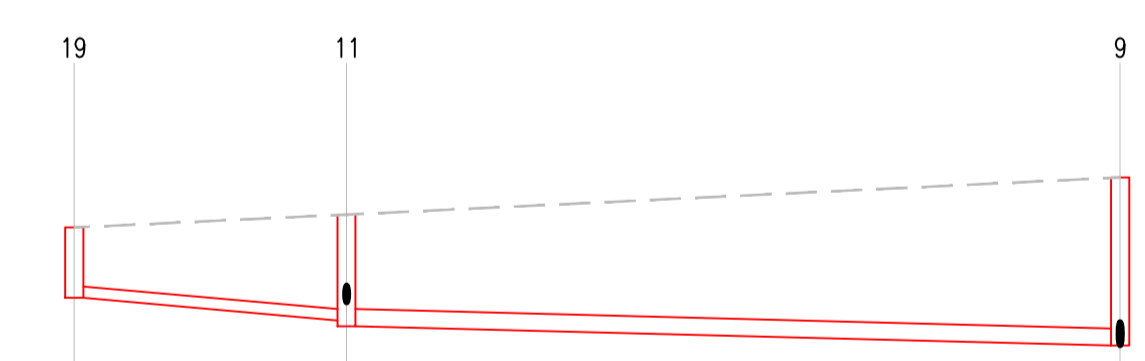

Datum = 90.0

Link Name	19	11	9
Section Type	150mm	225mm	225mm
Slope	1:60.0	1:199.9	1:199.9
Cover Level	92.830	93.000	93.491
Invert Level	91.900	91.600 91.525	91.269
Length	18.007	51.170	

Horizontal Scale 1:500
Vertical Scale 1:100

REFER TO DRAWING 21-111-P020-P023 FOR THE PLAN VIEW OF THE DRAINAGE LAYOUT

REV.	DATE	AMENDMENT	DRN	APPD
—	02/08/22	ISSUED FOR PLANNING	MS	EC

STATUS **FOR PLANNING ONLY**

Waterman Moylan
Engineering Consultants

BLOCK S, EASTPOINT BUSINESS PARK, ALFIE BYRNE ROAD,
DUBLIN D03 H3F4 IRELAND. Tel: (01) 664 8900
Email: info@waterman-moylan.ie www.waterman-moylan.ie

CLIENT **GRAFTON ISSUER DAC**
ARCHITECT **OMP ARCHITECTS**
PROJECT **RESIDENTIAL DEVELOPMENT AT CARRICMINES GREAT, GLENAMUCK ROAD SOUTH DUBLIN 18**

TITLE **FOUL LONG SECTIONS – SHEET 1 OF 2**

DRAWN	DESIGNED	APPROVED	DATE
MS	LRG	EC	JULY 2022
SCALE	JOB NO.	DRG. NO.	REVISION
AS SHOWN @A1	21-111	P040	—