



ALL TRENCHES IN EXPOSED ROCK TO BE LINED WITH LIQUID BITUMEN SPRAY IMMEDIATELY AFTER EXPOSURE.

- NOTES:
- DO NOT SCALE. USE FIGURED DIMENSIONS ONLY.
  - THIS DRAWING IS TO BE READ IN CONJUNCTION WITH ALL OTHER RELEVANT ARCHITECTURAL AND ENGINEERING DRAWINGS.

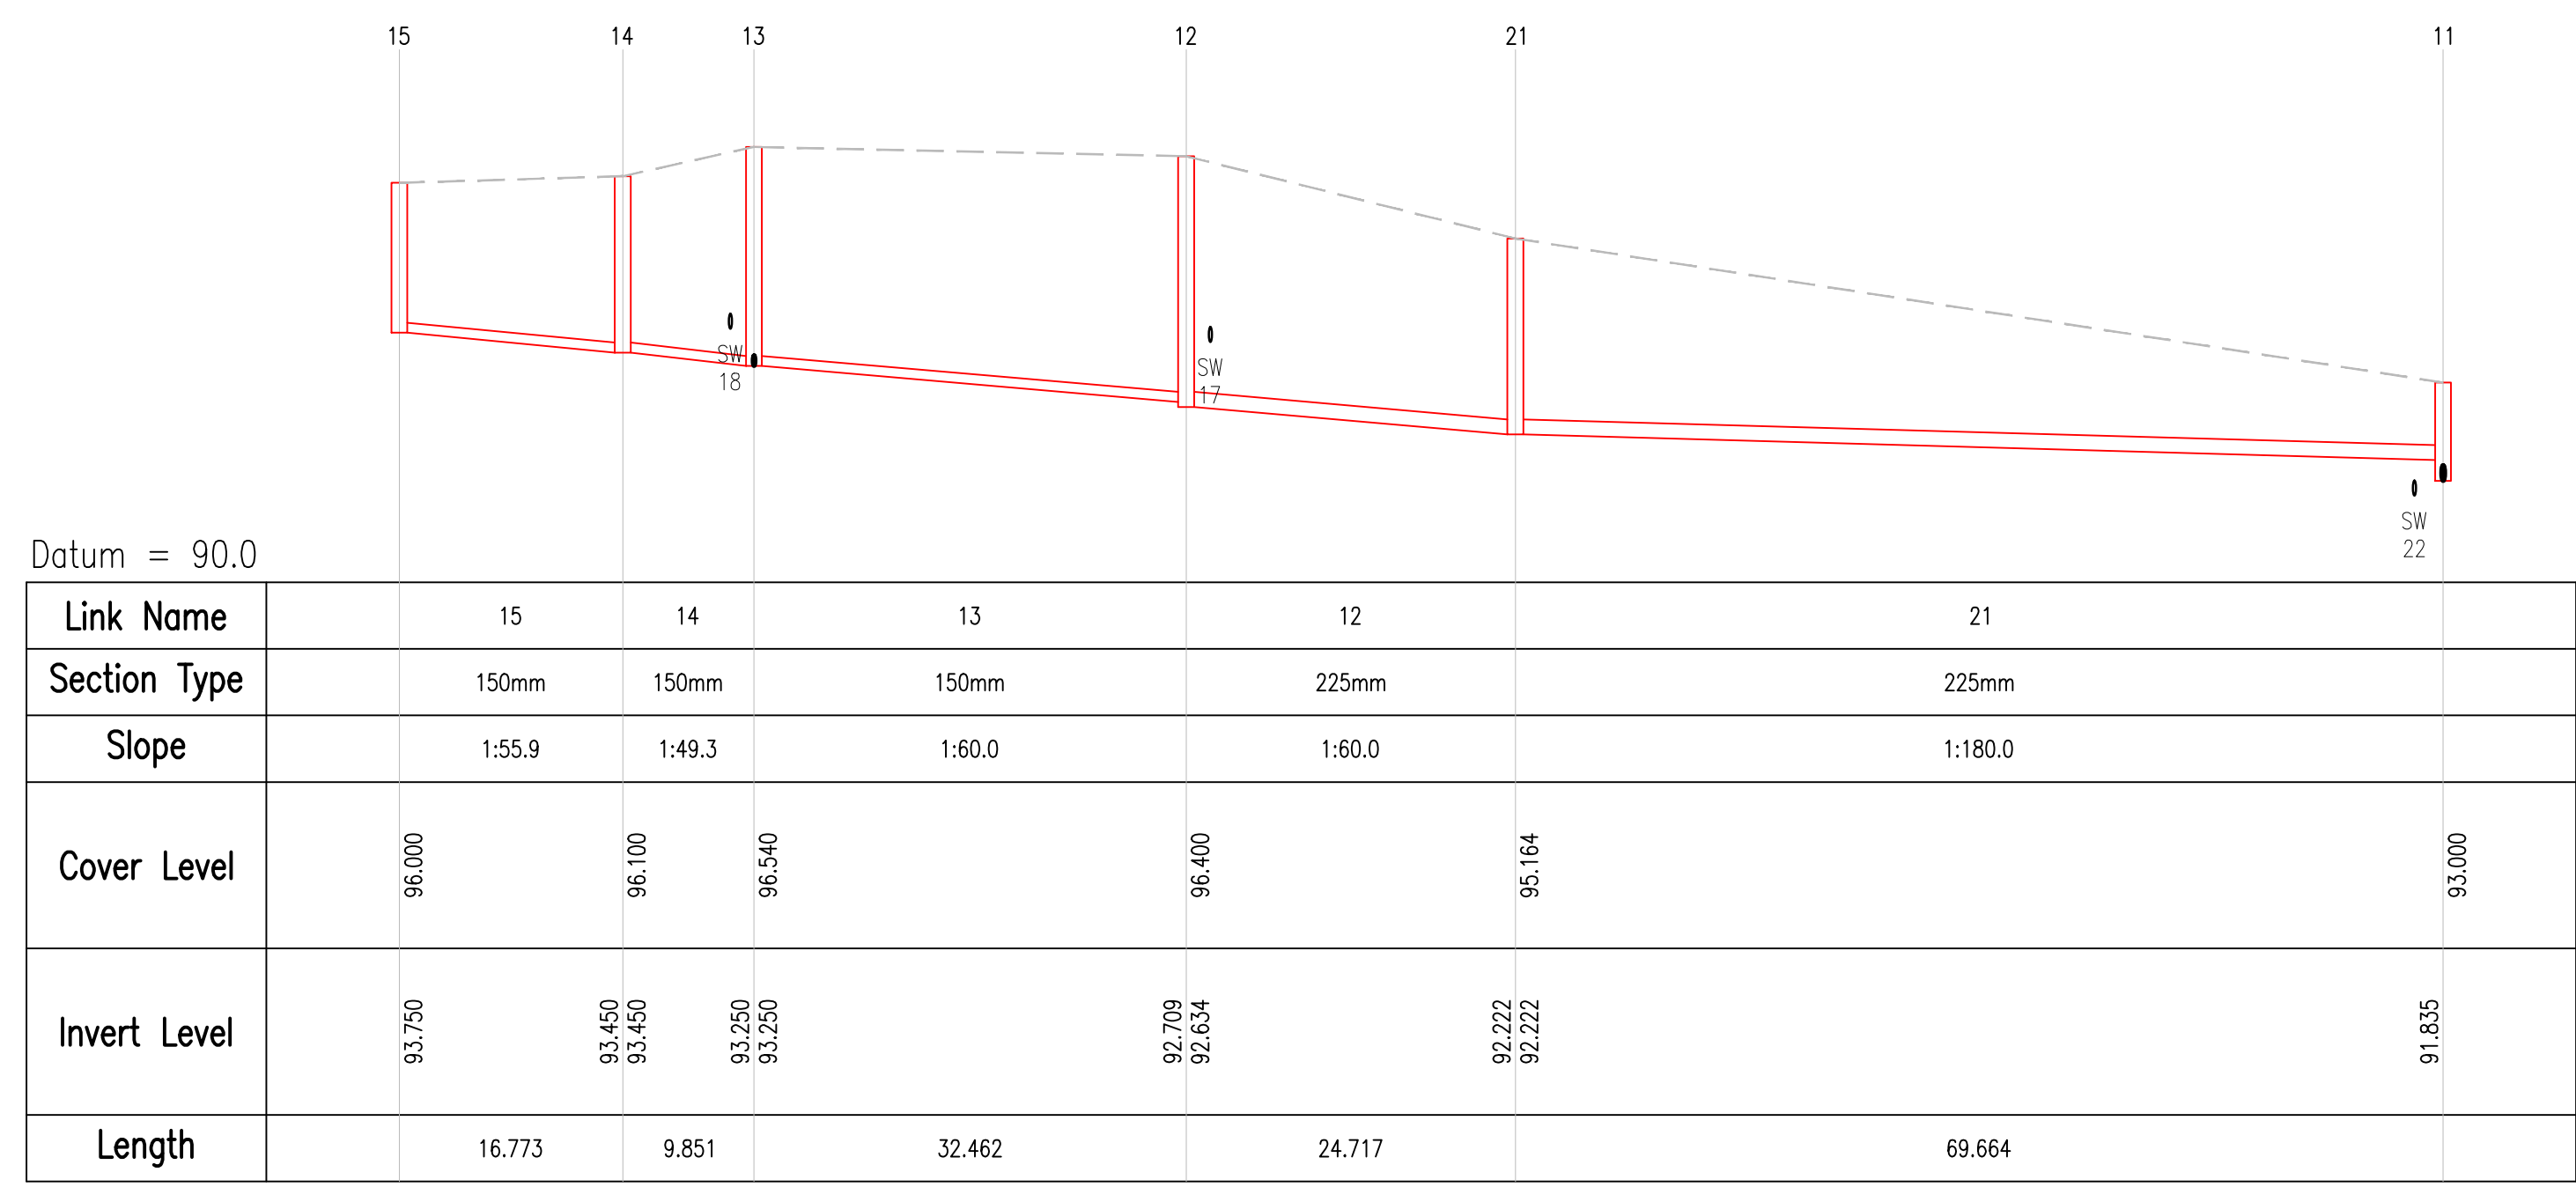


Datum = 90.0

Horizontal Scale 1:500  
Vertical Scale 1:100

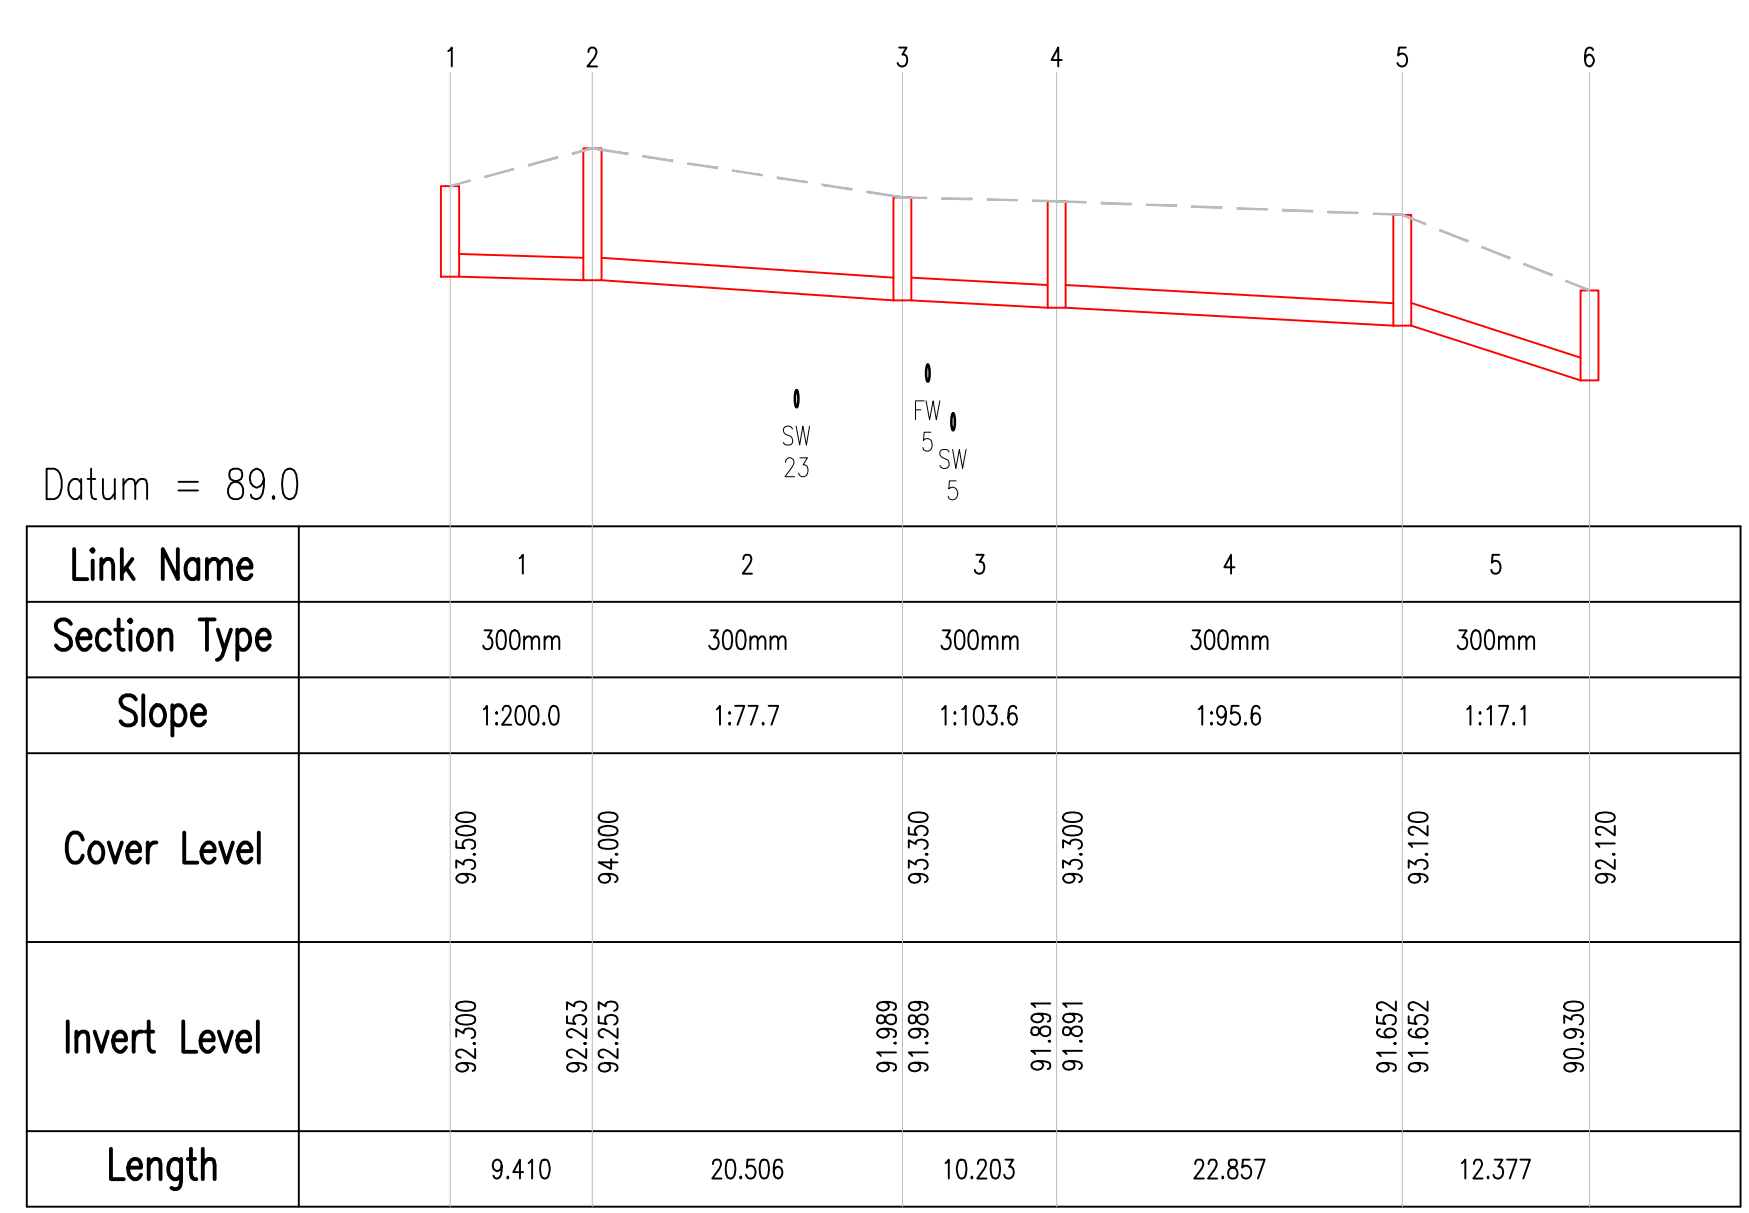


Datum = 89.0

Horizontal Scale 1:500  
Vertical Scale 1:100

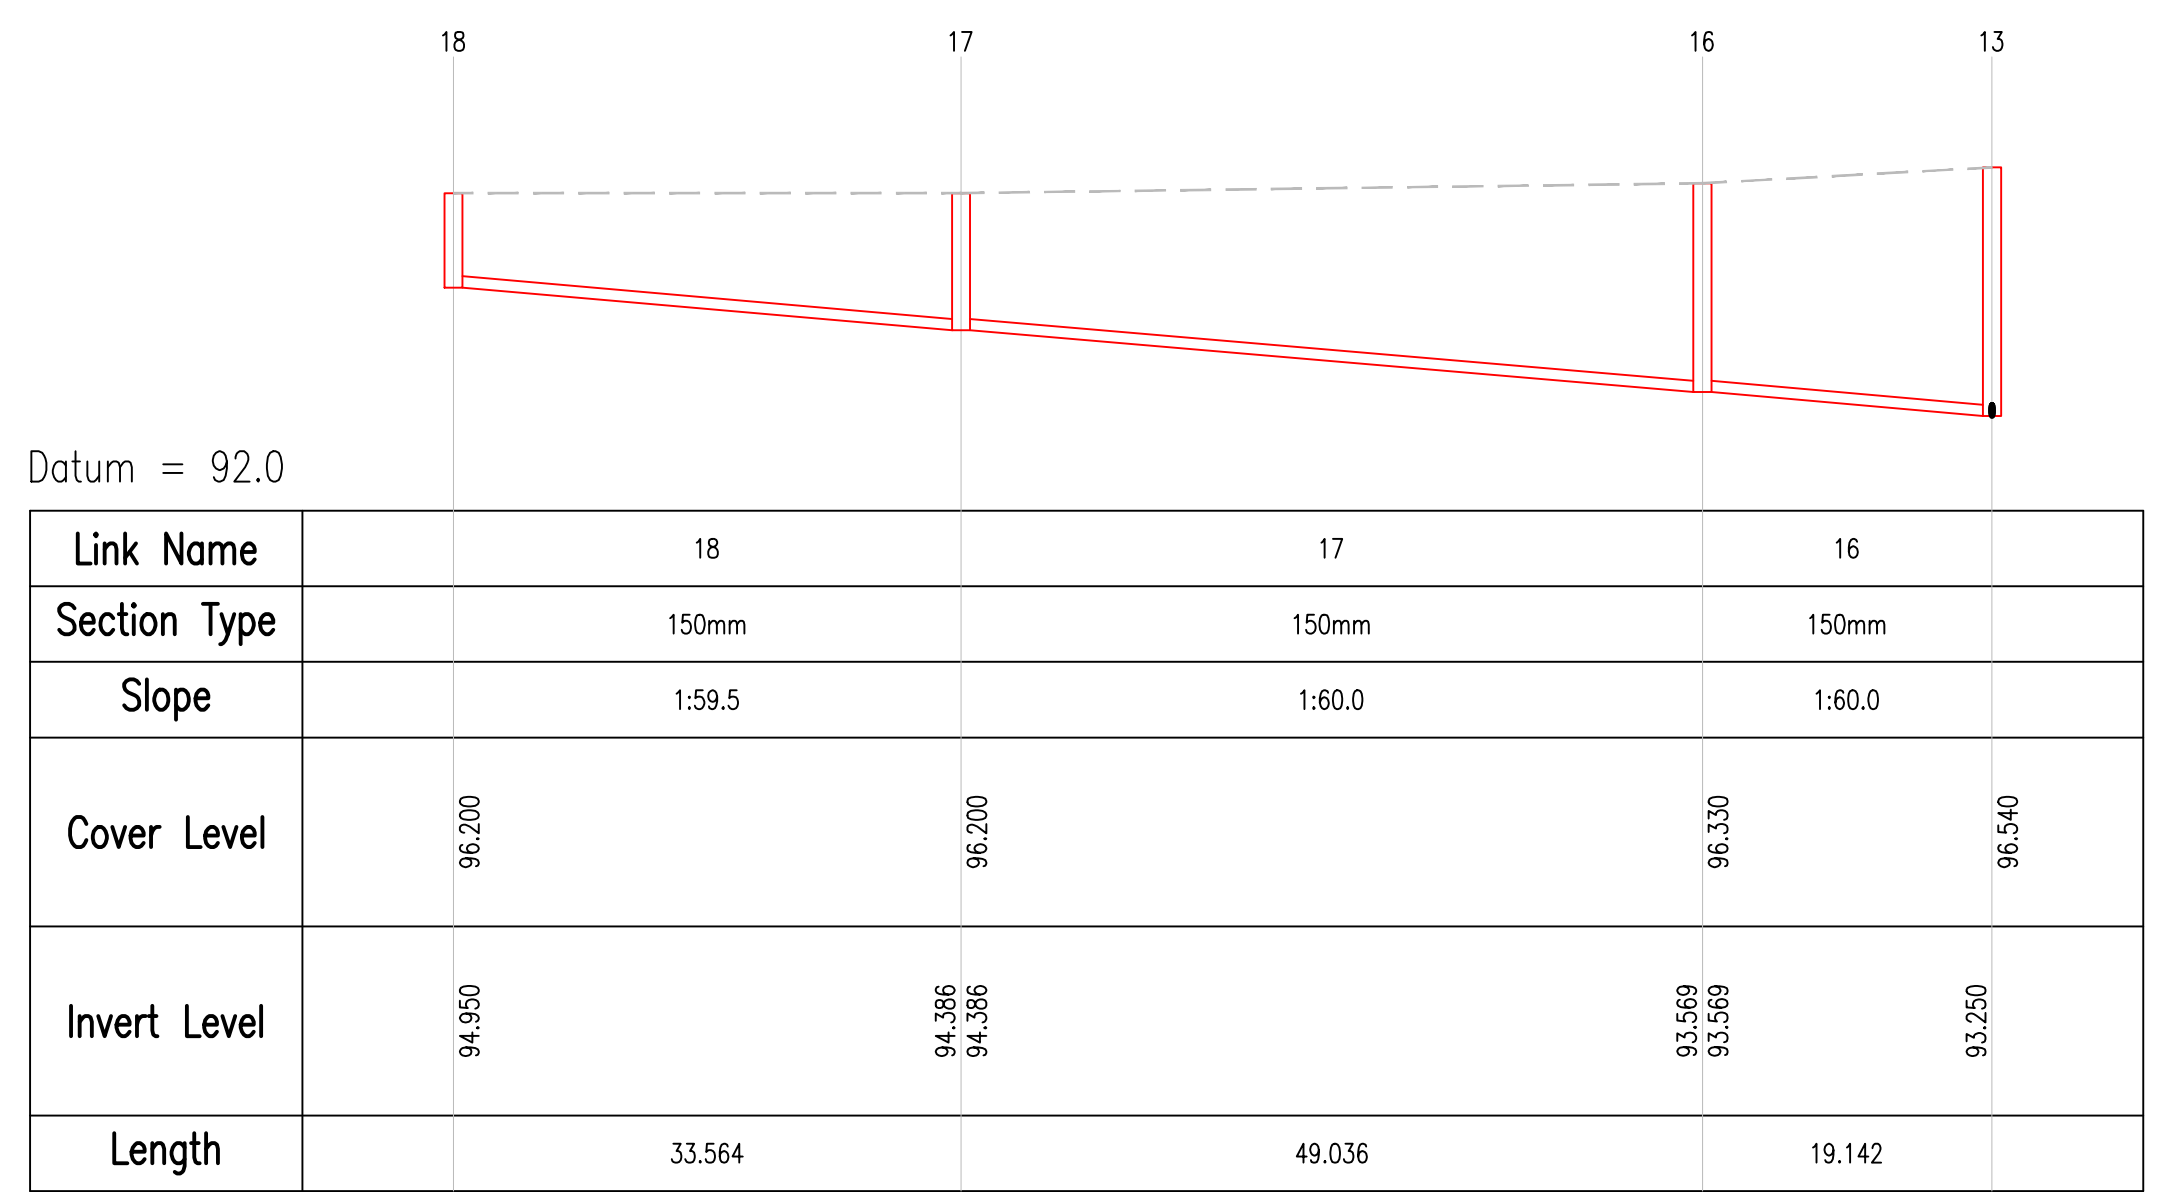

Datum = 92.0

Horizontal Scale 1:500  
Vertical Scale 1:100

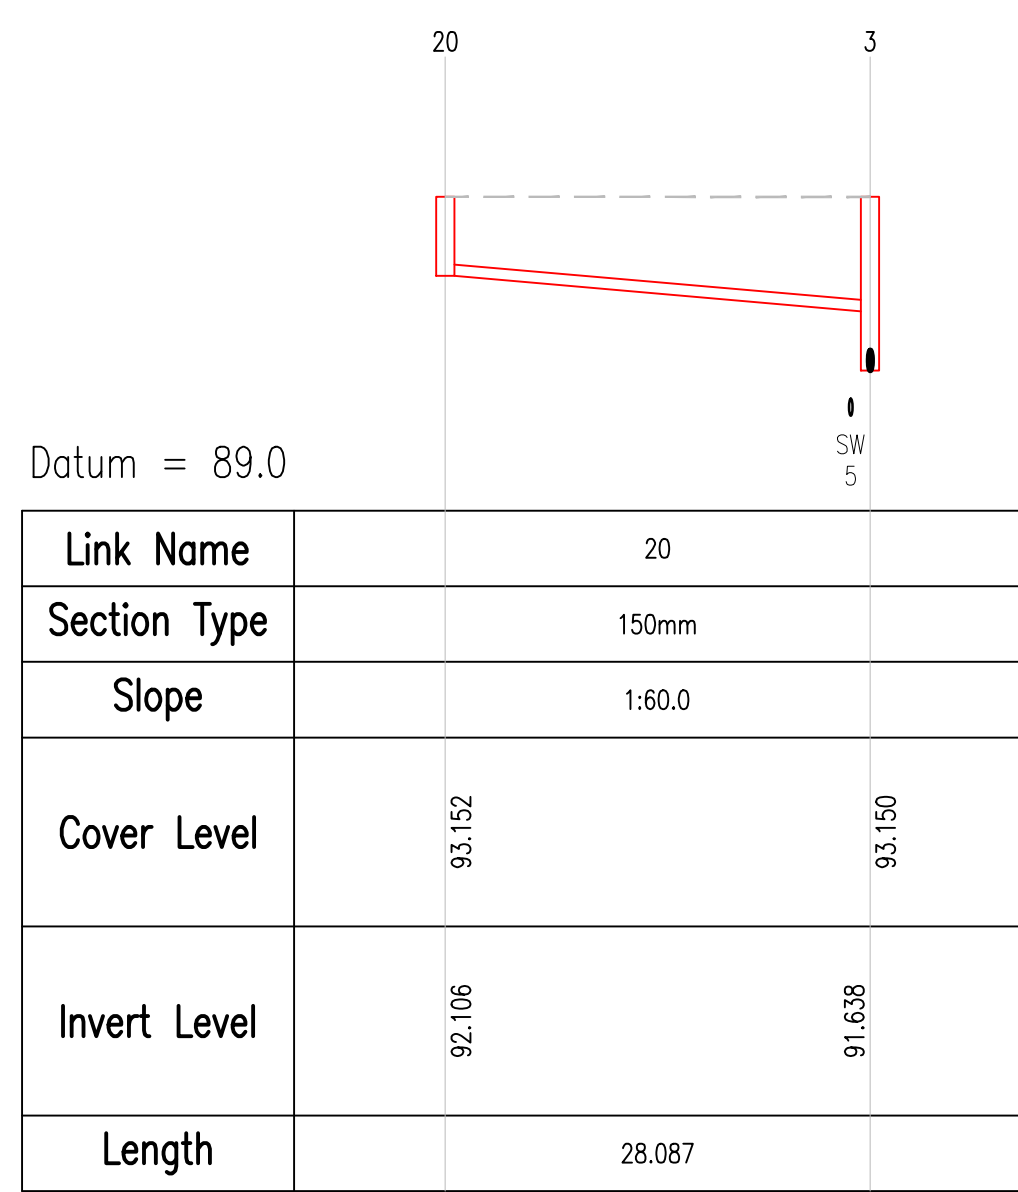

Datum = 89.0

Horizontal Scale 1:500  
Vertical Scale 1:100

REFER TO DRAWING 21-111-P020-P023 FOR THE PLAN VIEW OF THE DRAINAGE LAYOUT

|      |          |                     |     |      |
|------|----------|---------------------|-----|------|
| REV. | 02/08/22 | ISSUED FOR PLANNING | MS  | EC   |
| REV. | DATE     | AMENDMENT           | DRN | APPD |

STATUS **FOR PLANNING ONLY**

**Waterman Moylan**  
Engineering Consultants

BLOCK S, EASTPOINT BUSINESS PARK, ALFIE BYRNE ROAD,  
DUBLIN D03 H3F4 IRELAND. Tel: (01) 664 8900  
Email: info@waterman-moylan.ie www.waterman-moylan.ie

|           |  |
|-----------|--|
| CLIENT    | GRAFTON ISSUER DAC   |
| ARCHITECT | OMP ARCHITECTS   |
| PROJECT   | RESIDENTIAL DEVELOPMENT AT CARRICMINES GREAT, GLENAMUCK ROAD SOUTH DUBLIN 18 |
| TITLE     | FOUL LONG SECTIONS - SHEET 2 OF 2  |

|              |          |          |           |
|--------------|----------|----------|-----------|
| DRAWN        | DESIGNED | APPROVED | DATE      |
| MS           | LRG      | EC       | JULY 2022 |
| SCALE        | JOB NO.  | DRG. NO. | REVISION  |
| AS SHOWN @A1 | 21-111   | P041     |           |