


NOTES:


- DO NOT SCALE. USE FIGURED DIMENSIONS ONLY.
- THIS DRAWING IS TO BE READ IN CONJUNCTION WITH ALL OTHER RELEVANT ARCHITECTURAL AND ENGINEERING DRAWINGS.

ALL TRENCHES IN EXPOSED ROCK TO BE LINED WITH LIQUID BITUMEN SPRAY IMMEDIATELY AFTER EXPOSURE.

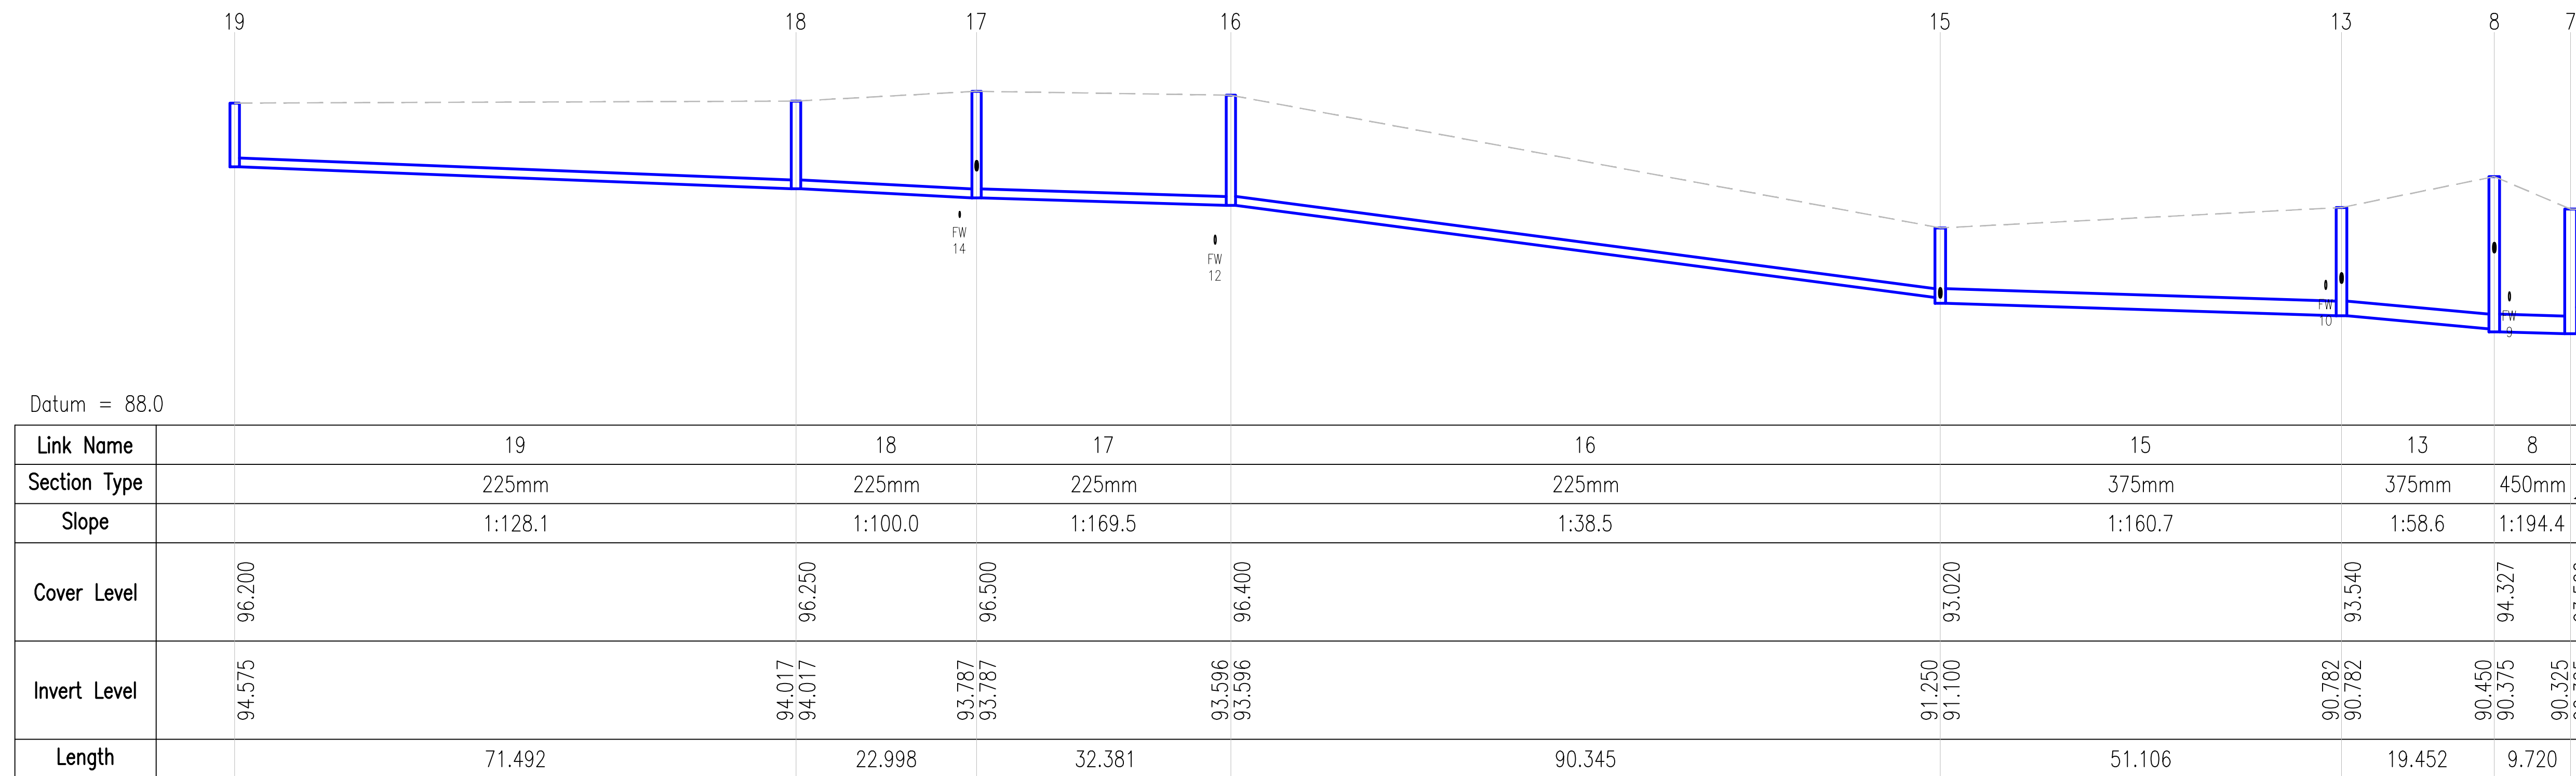


Datum = 88.0

Horizontal Scale 1:500
Vertical Scale 1:100

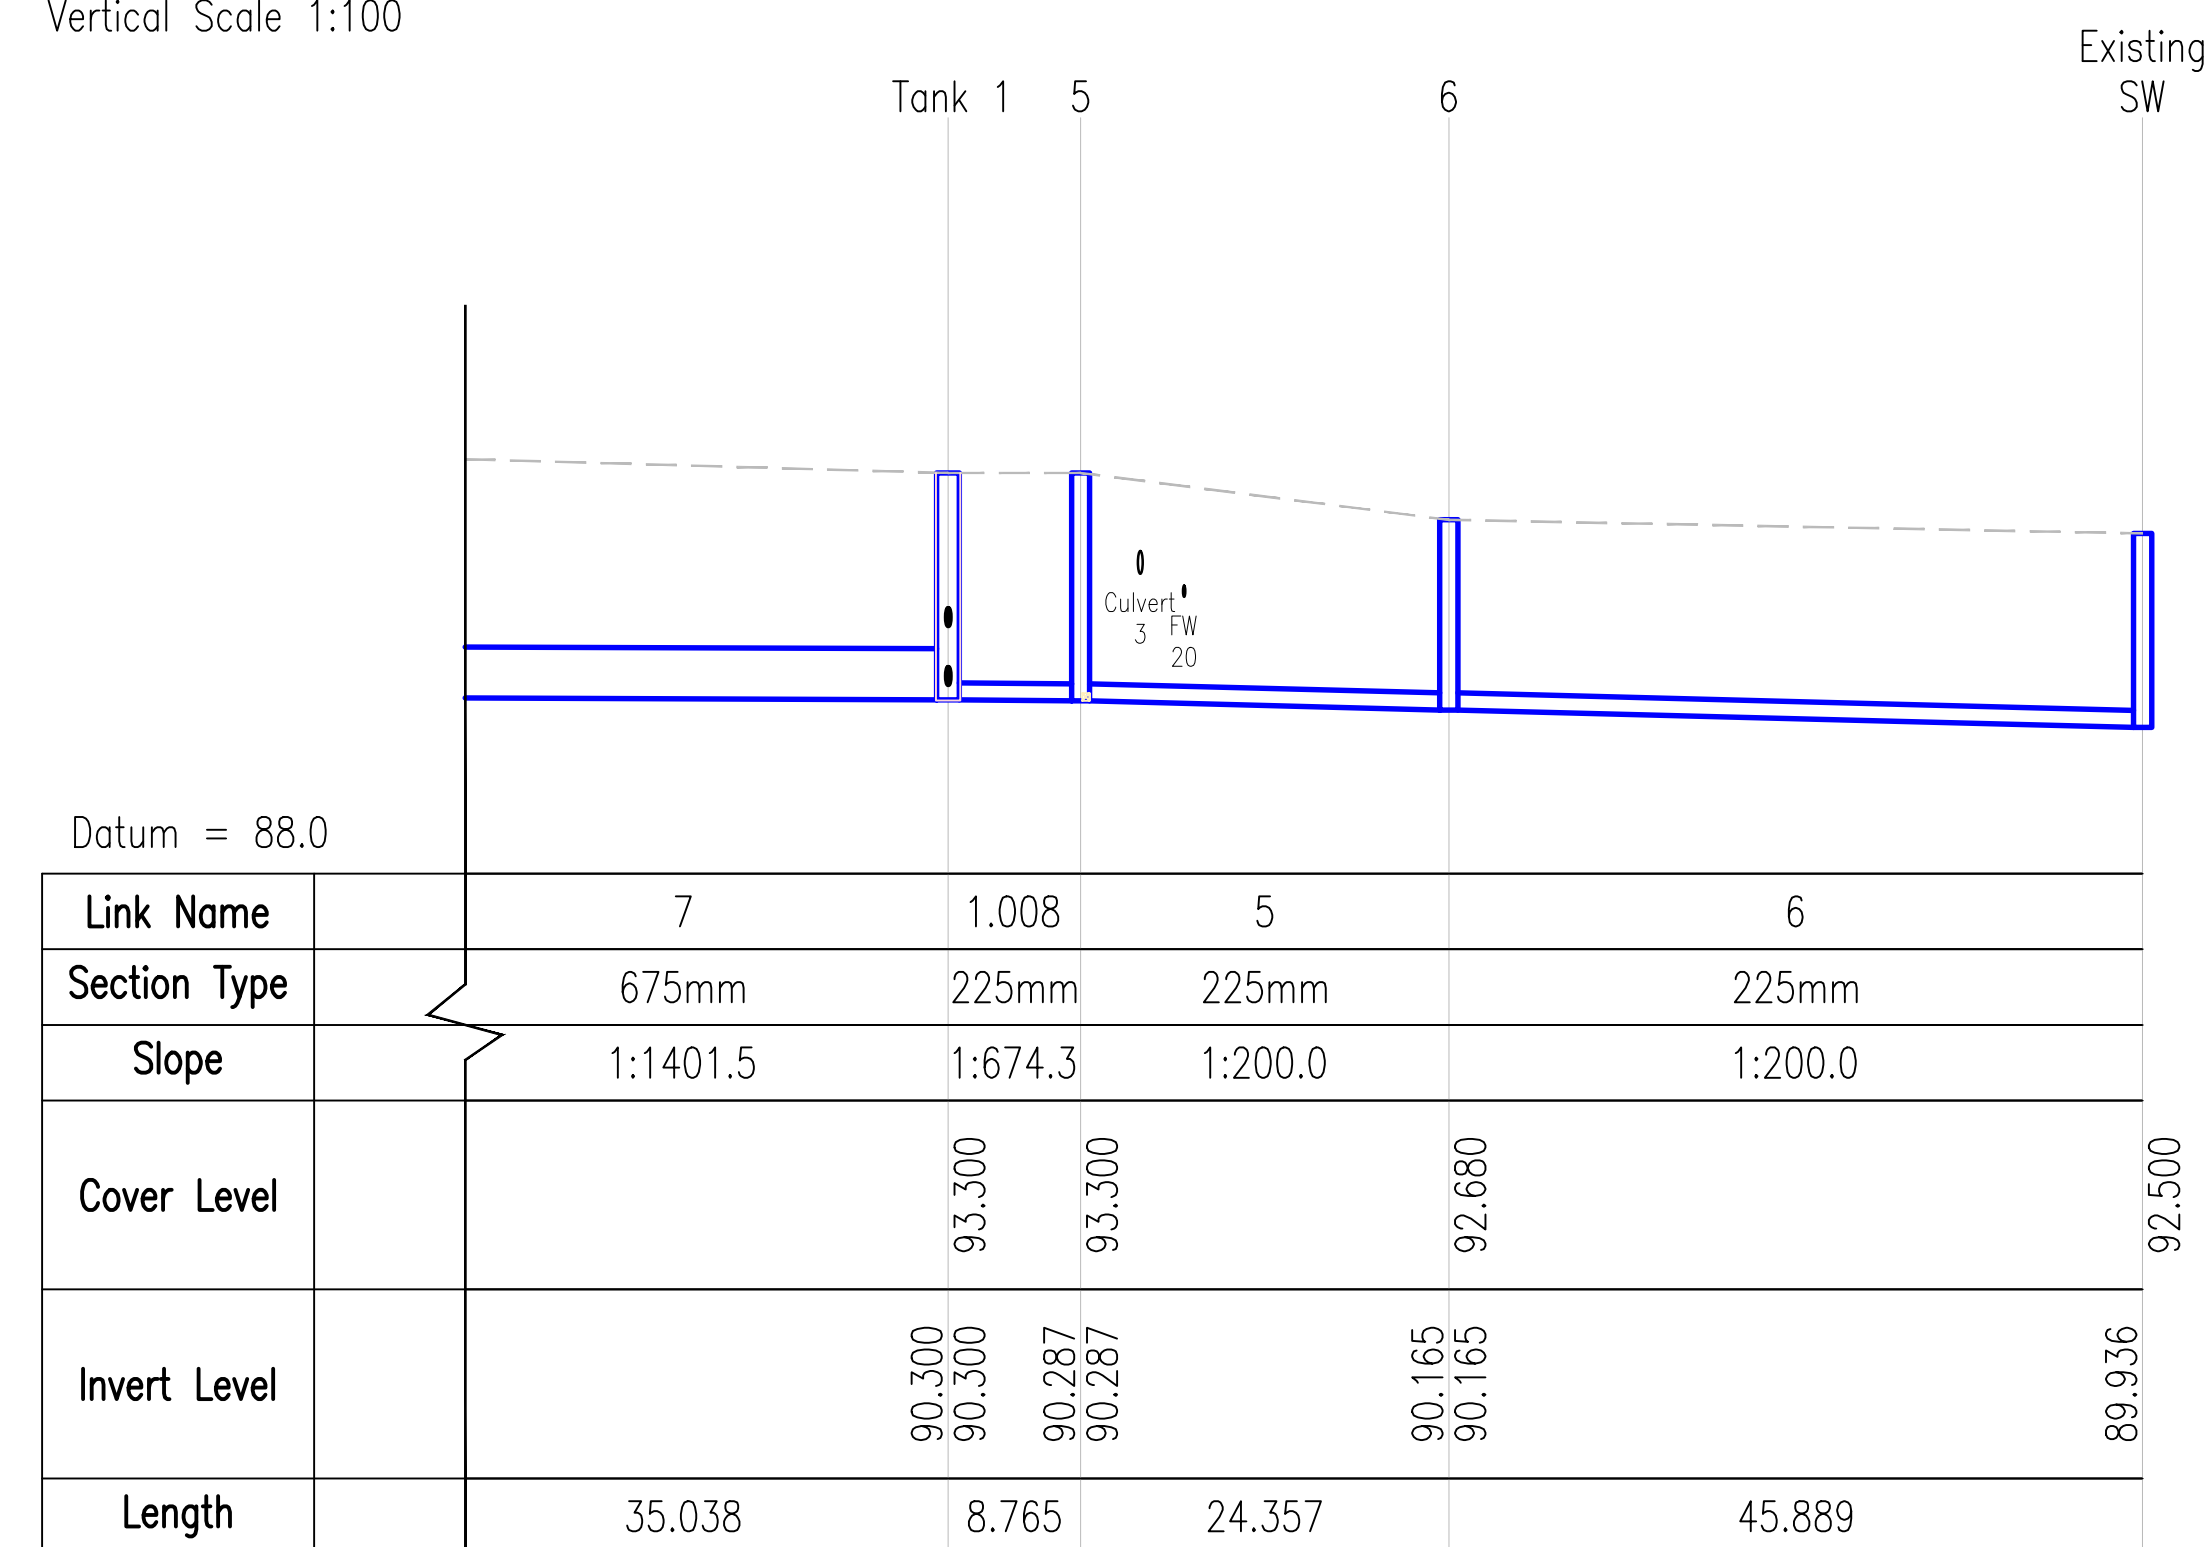


Datum = 88.0

Horizontal Scale 1:500
Vertical Scale 1:100

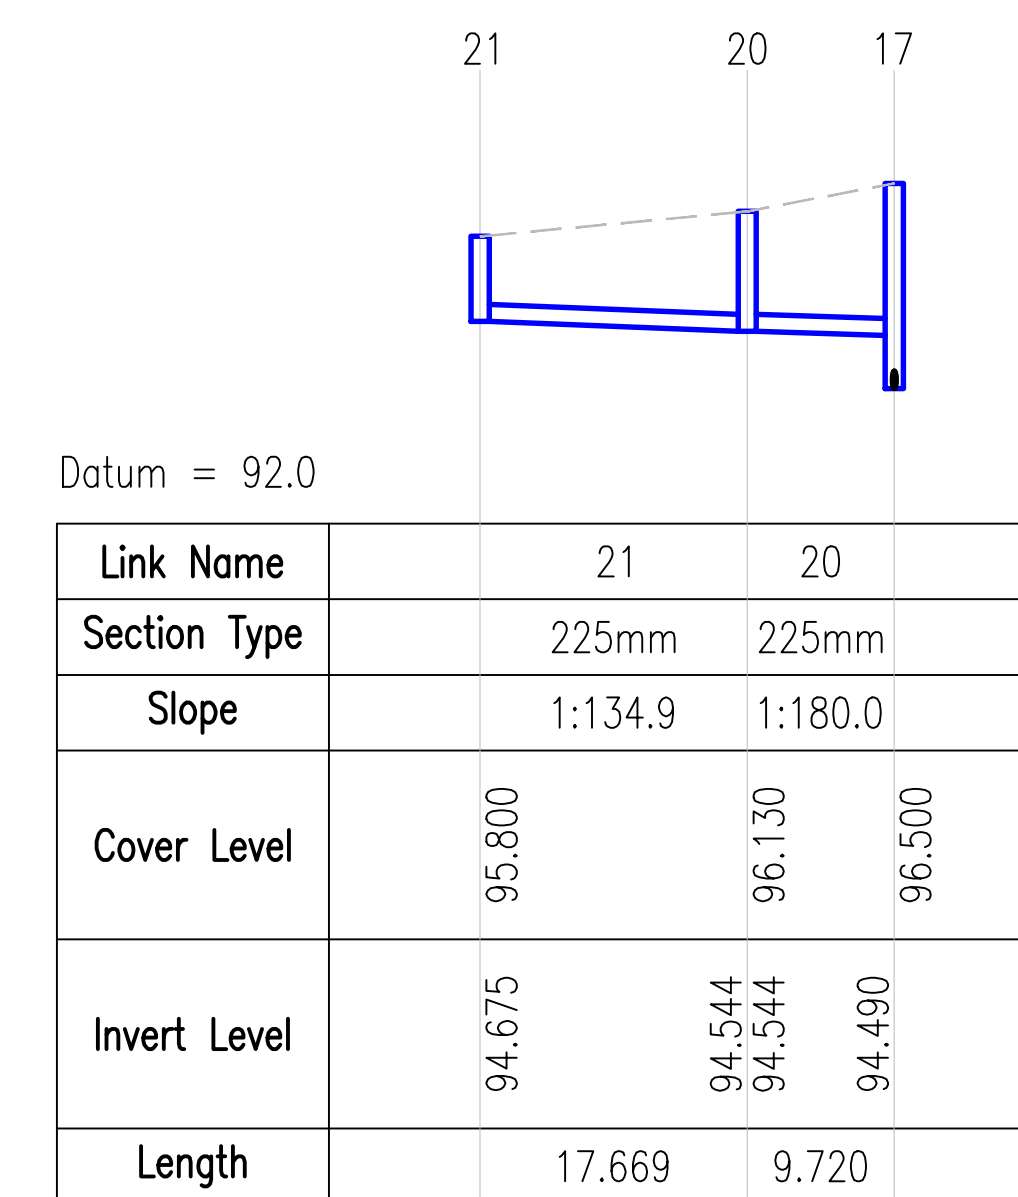

Datum = 92.0

Horizontal Scale 1:500
Vertical Scale 1:100

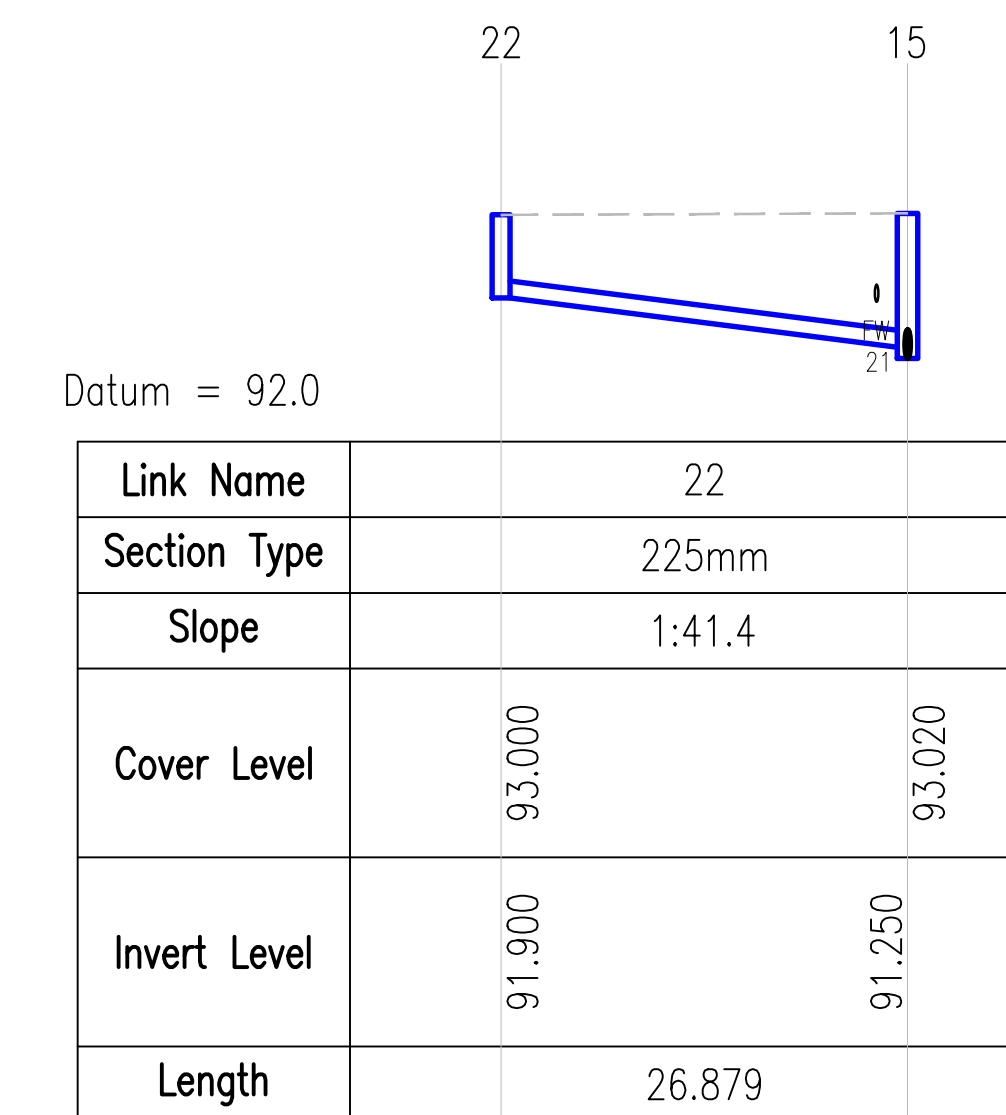

Datum = 92.0

Horizontal Scale 1:500
Vertical Scale 1:100

REFER TO DRAWING 21-111-P020-P023 FOR THE PLAN VIEW OF THE DRAINAGE LAYOUT

REV.	DATE	AMENDMENT	DRN	APPD
-	02/08/22	ISSUED FOR PLANNING	MS	EC

STATUS **FOR PLANNING ONLY**

Waterman Moylan
Engineering Consultants

BLOCK 8, EASTPOINT BUSINESS PARK, ALFIE BYRNE ROAD,
DUBLIN D03 H3F4 IRELAND. Tel: (01) 664 8900
Email: info@waterman-moylan.ie www.waterman-moylan.ie

CLIENT **GRAFTON ISSUER DAC**
ARCHITECT **OMP ARCHITECTS**
PROJECT **RESIDENTIAL DEVELOPMENT AT CARRICMINES GREAT, GLENAMUCK ROAD SOUTH DUBLIN 18**

TITLE
SURFACE WATER LONG SECTIONS - SHEET 1 OF 2

DRAWN MS	DESIGNED LRG	APPROVED EC	DATE JULY 2022
SCALE AS SHOWN @A1	JOB NO. 21-111	DRG. NO. P042	REVISION